


This Layout is to 1/4"=1' Scale

DIGITAL

UNIVERSE





This Layout is to 1/4"=1' Scale

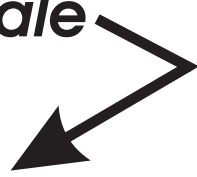

*This Photo Layout is
is Visually DISTORTED Scale*



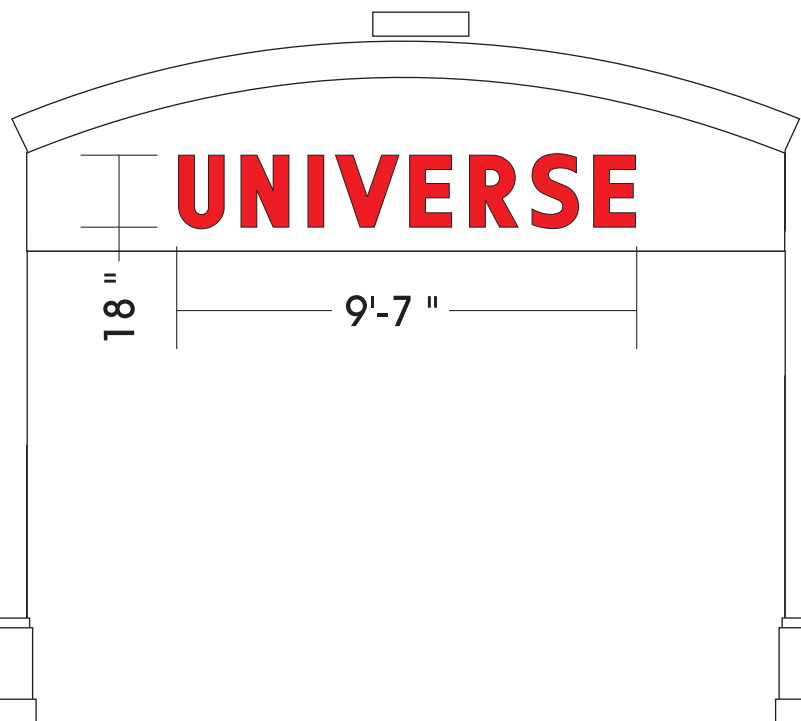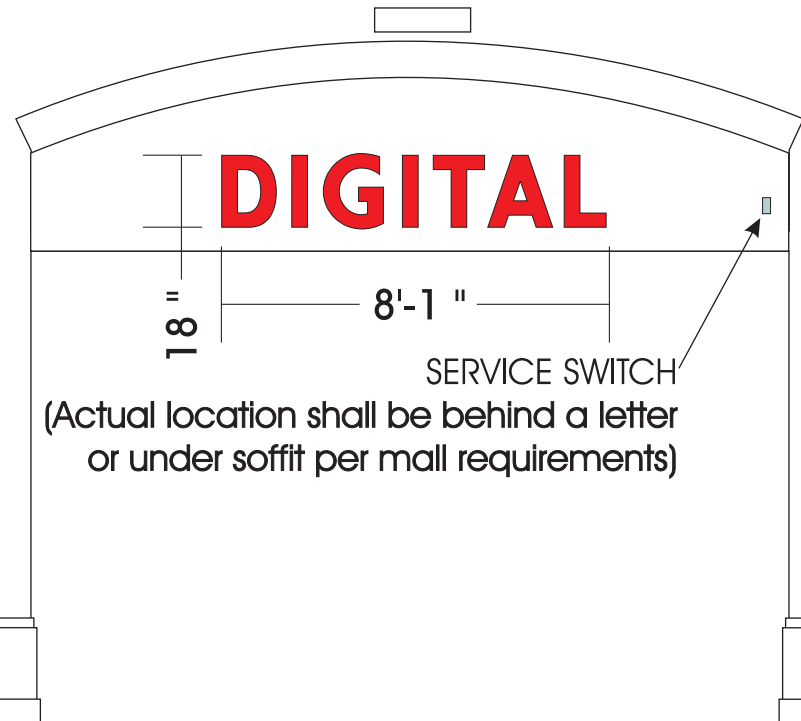

DOLPHIN MALL INTERIOR
EAST ELEVATION
SCALE 1/4" = 1'

MALL SPACE "E-418" RED Reverse Channel Letter Sign
with RED Halo

DIGITAL UNIVERSE

12 Sq Ft 13.5 Sq Ft
Total 26 Sq Ft Sign



Certified Sign
Manufacturer
UXYT.E202255
ELECTRO GRAPHICS

JOB NAME: DIGITAL UNIVERSE
LOCATION: Dolphin Mall # E-418 Miami-Dade, FL 330xx
October 25, 2004
DRAWN BY: Paul SCALE: As Noted

Electro Graphics, Power, Lighting, & Signs, Inc. State: ER13012733
Dade CC 93E000533 Project Manager: Paul Diaz (786) 251-9254
<small>This is an unpublished drawing, created by E. G. P. L. & S., Inc. It is submitted for your personal use in connection with a project being planned for you by E. G. P. L. & S., Inc. It is not to be shown to anyone outside your organization, nor is it to be used, reproduced, copied, or elicited in any fashion whatsoever. All or any part of this design (except registered trademarks) remain the property of E. G. P. L. & S., Inc.</small>

TYPICAL INSTALLATION
COMPONENT LOCATION MAY VARY

SERVICE SWITCH per NEC 600
 (Actual location shall be behind a letter
 or under soffit per mall requirements)

3 1/2" ALUMINUM RETURN

TRANSFORMER
 UL 2161 IN ENCLOSURE

NEON TUBING

STD. #10-T GLASS TUBE SUPPORT
 ALUMINUM FACE

SECONDARY ELECTRICAL
 GTO-15

ELECTRICAL CONDUIT

LEXAN BACK

DRYWIT OR WALLBOARD FASCIA

WEEP HOLE
 NOT REQUIRED FOR INTERIOR

ALL-THREAD, TOGGLE, OR SCREW

STUD WALL

PRIMARY MIN # 12 THHN/TWWN
 IN 1/2" CONDUIT

20 AMP Main
 DISCONNECT SWITCH

TRANSFORMERS ARE UL-2161 GFI AS REQUIRED

1-12000/30 (3 AMP)


1- 9000/30 (2.4 AMP)

TOTAL LOAD 5.4 AMP

ONE (1) 20 AMP SIGN CKT (#9) (min #12 THWN)

ALL COMPONENTS ARE UL LISTED

GROUNDING PER NEC 250

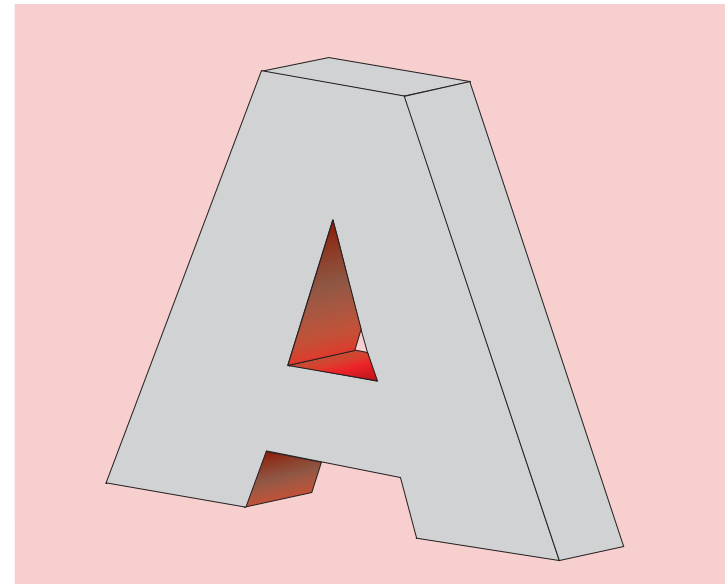

Certified Sign
 Manufacturer
 # UXYT.E202255
 ELECTRO GRAPHICS

JOB NAME: DIGITAL UNIVERSE
LOCATION: Dolphin Mall # E-418
Miami-Dade, FL 330xx
October 25, 2004
DRAWN BY: Paul SCALE: As Noted

Electro Graphics, Power, Lighting, & Signs, Inc. State: ER13012733
Dade CC 93E000533
Project Manager: Paul Diaz (786) 251-9254
<small>This is an unpublished drawing, created by E. G. P. L. & S. Inc. It is submitted for your personal use in connection with a project being planned for you by E. G. P. L. & S. Inc. It is not to be shown to anyone outside your organization, nor is it to be used, reproduced, copied, or elicited in any fashion whatsoever. All or any part of this design (except registered trademarks) remain the property of E. G. P. L. & S. Inc.</small>